
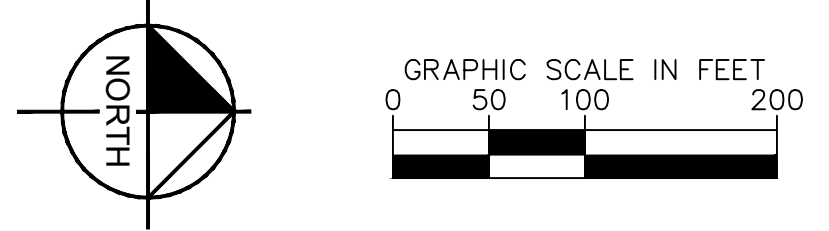


Drawing name: K:\CB\_LIVE\190146000 Peachblow 47 Ac - Berlin\_Twp\2 Design\CAD\Utilities\2023-0306\_Updated Utility Plan.dwg Layout1 Mar 06, 2023 9:46am by: Rick McGreal  
 This document, together with the concepts and designs presented herein, is intended only for the specific purpose and client for which it was prepared. Reuse of and improper reliance on this document without written authorization and adaptation by Kimley-Horn and Associates, Inc. shall be without liability to Kimley-Horn and Associates, Inc.

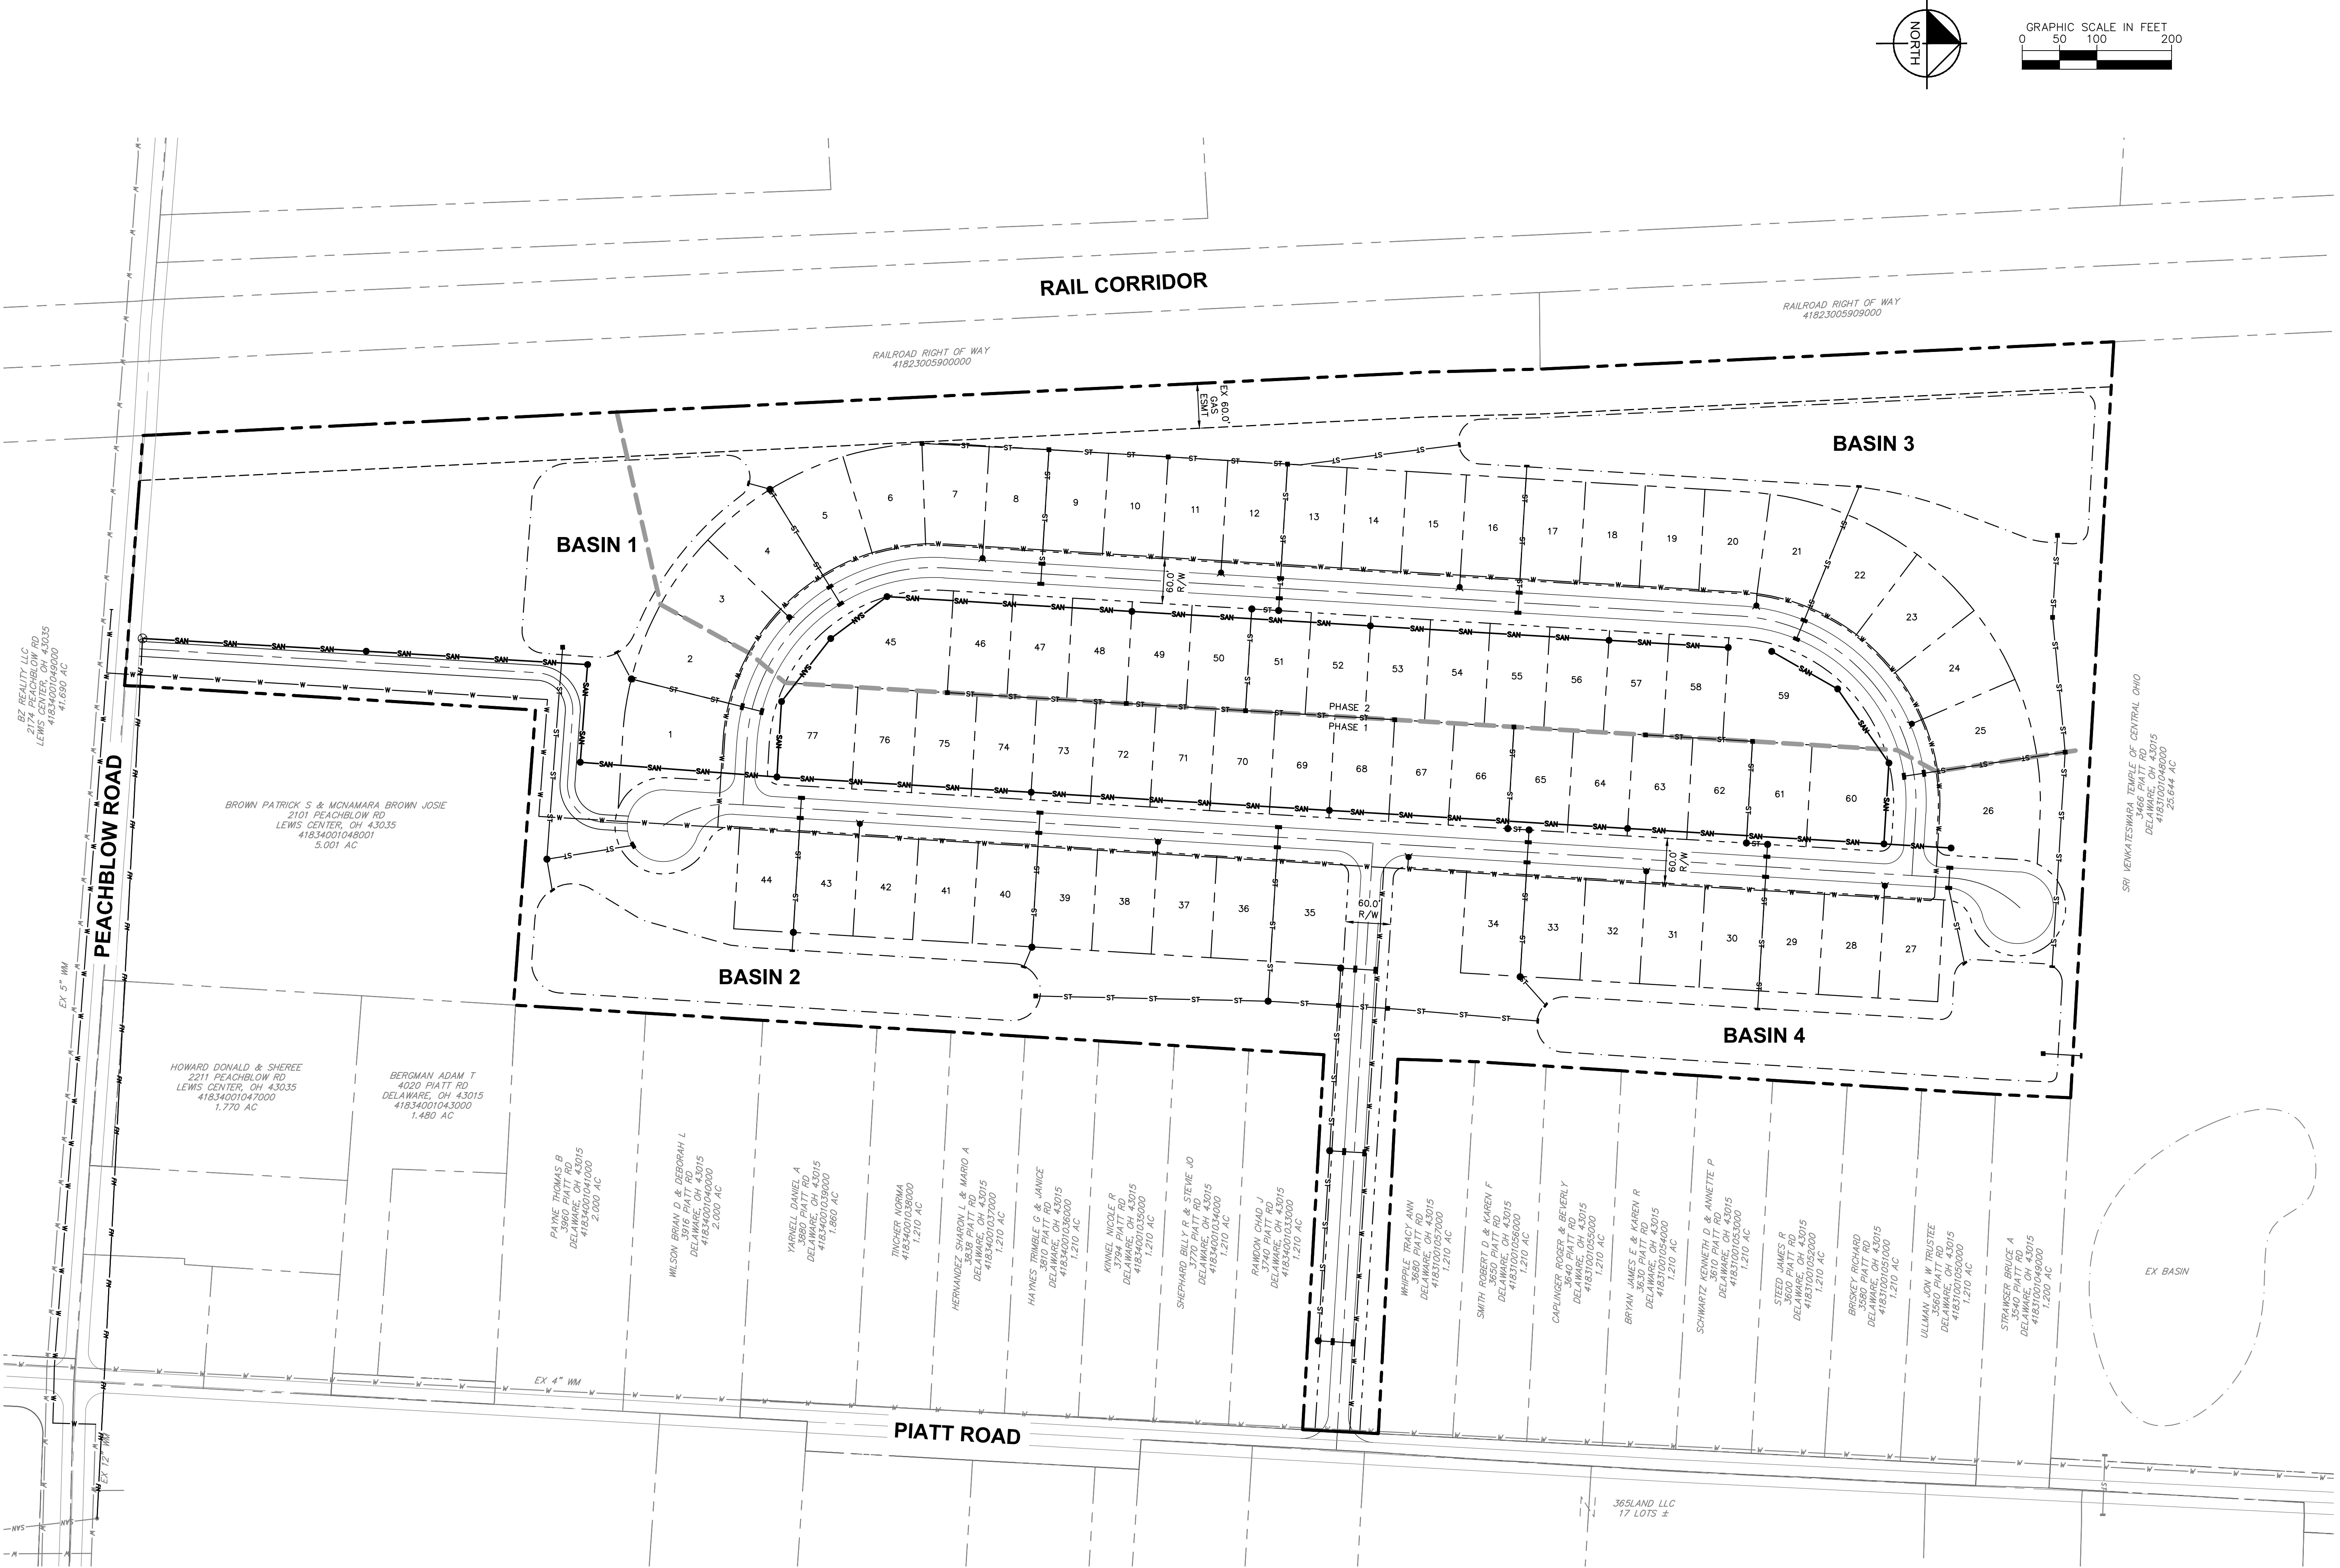

No.	REVISIONS	DATE	BY

**Kimley»Horn**  
 © 2022 KIMLEY-HORN AND ASSOCIATES, INC.  
 7965 N HIGH STREET, SUITE 200  
 COLUMBUS, OH 43235  
 WWW.KIMLEY-HORN.COM

SCALE:  
 AS NOTED  
 DESIGNED BY: SMV  
 DRAWN BY: ANF  
 CHECKED BY: KDK

**PRELIMINARY UTILITY  
 AND DRAINAGE PLAN**

**PEACHBLOW ROAD**  
 BERLIN TOWNSHIP, DELAWARE COUNTY, OHIO

ORIGINAL ISSUE:  
 3/6/2022  
 KHA PROJECT NO.

SHEET NUMBER  
**1 OF 1**

**epa**  
**EYERMAN PLANNING ASSOCIATES, LLC**  
 1907 RIVER ROAD DELAWARE, OH 43015 (614) 420-5547